

5 HJW a Ybh7

DRAWN BY: R.W. DESIGN BY: R.K.A.
CHCKD BY: C.W.P. PROJ. NO. 17-1740
ORIGINAL DATE: JANUARY 02, 2018


DATE	REVISION DESCRIPTION
01.23.2018	CITY COMMENTS
02.12.2018	REVISED UNITS
02.15.2018	ADD STORAGE TANK
03.09.2018	CITY COMMENTS
05.17.2018	NEW LAYOUT

I hereby certify that this plan was prepared by me or under my direct supervision and that I am a duly Licensed Professional Engineer under the laws of the State of Minnesota.


Charles W. Plowe
 LICENSE NO. 42761
 DATE: 05.17.2018

LAKE JOHANNA STATION 1
 ARDEN HILLS, MINNESOTA
 CIVIL SITE PLAN


PREPARED FOR: JOURNEY HOME MN

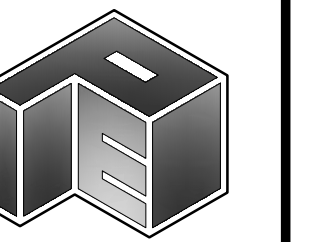

PLOWE ENGINEERING, INC.
 6776 LAKE DRIVE
 SUITE 110
 LINO LAKES, MN 55014
 PHONE: (651) 361-8210
 FAX: (651) 361-8701

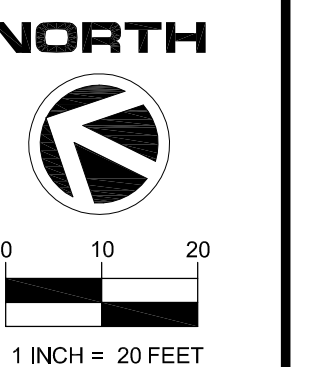

C3

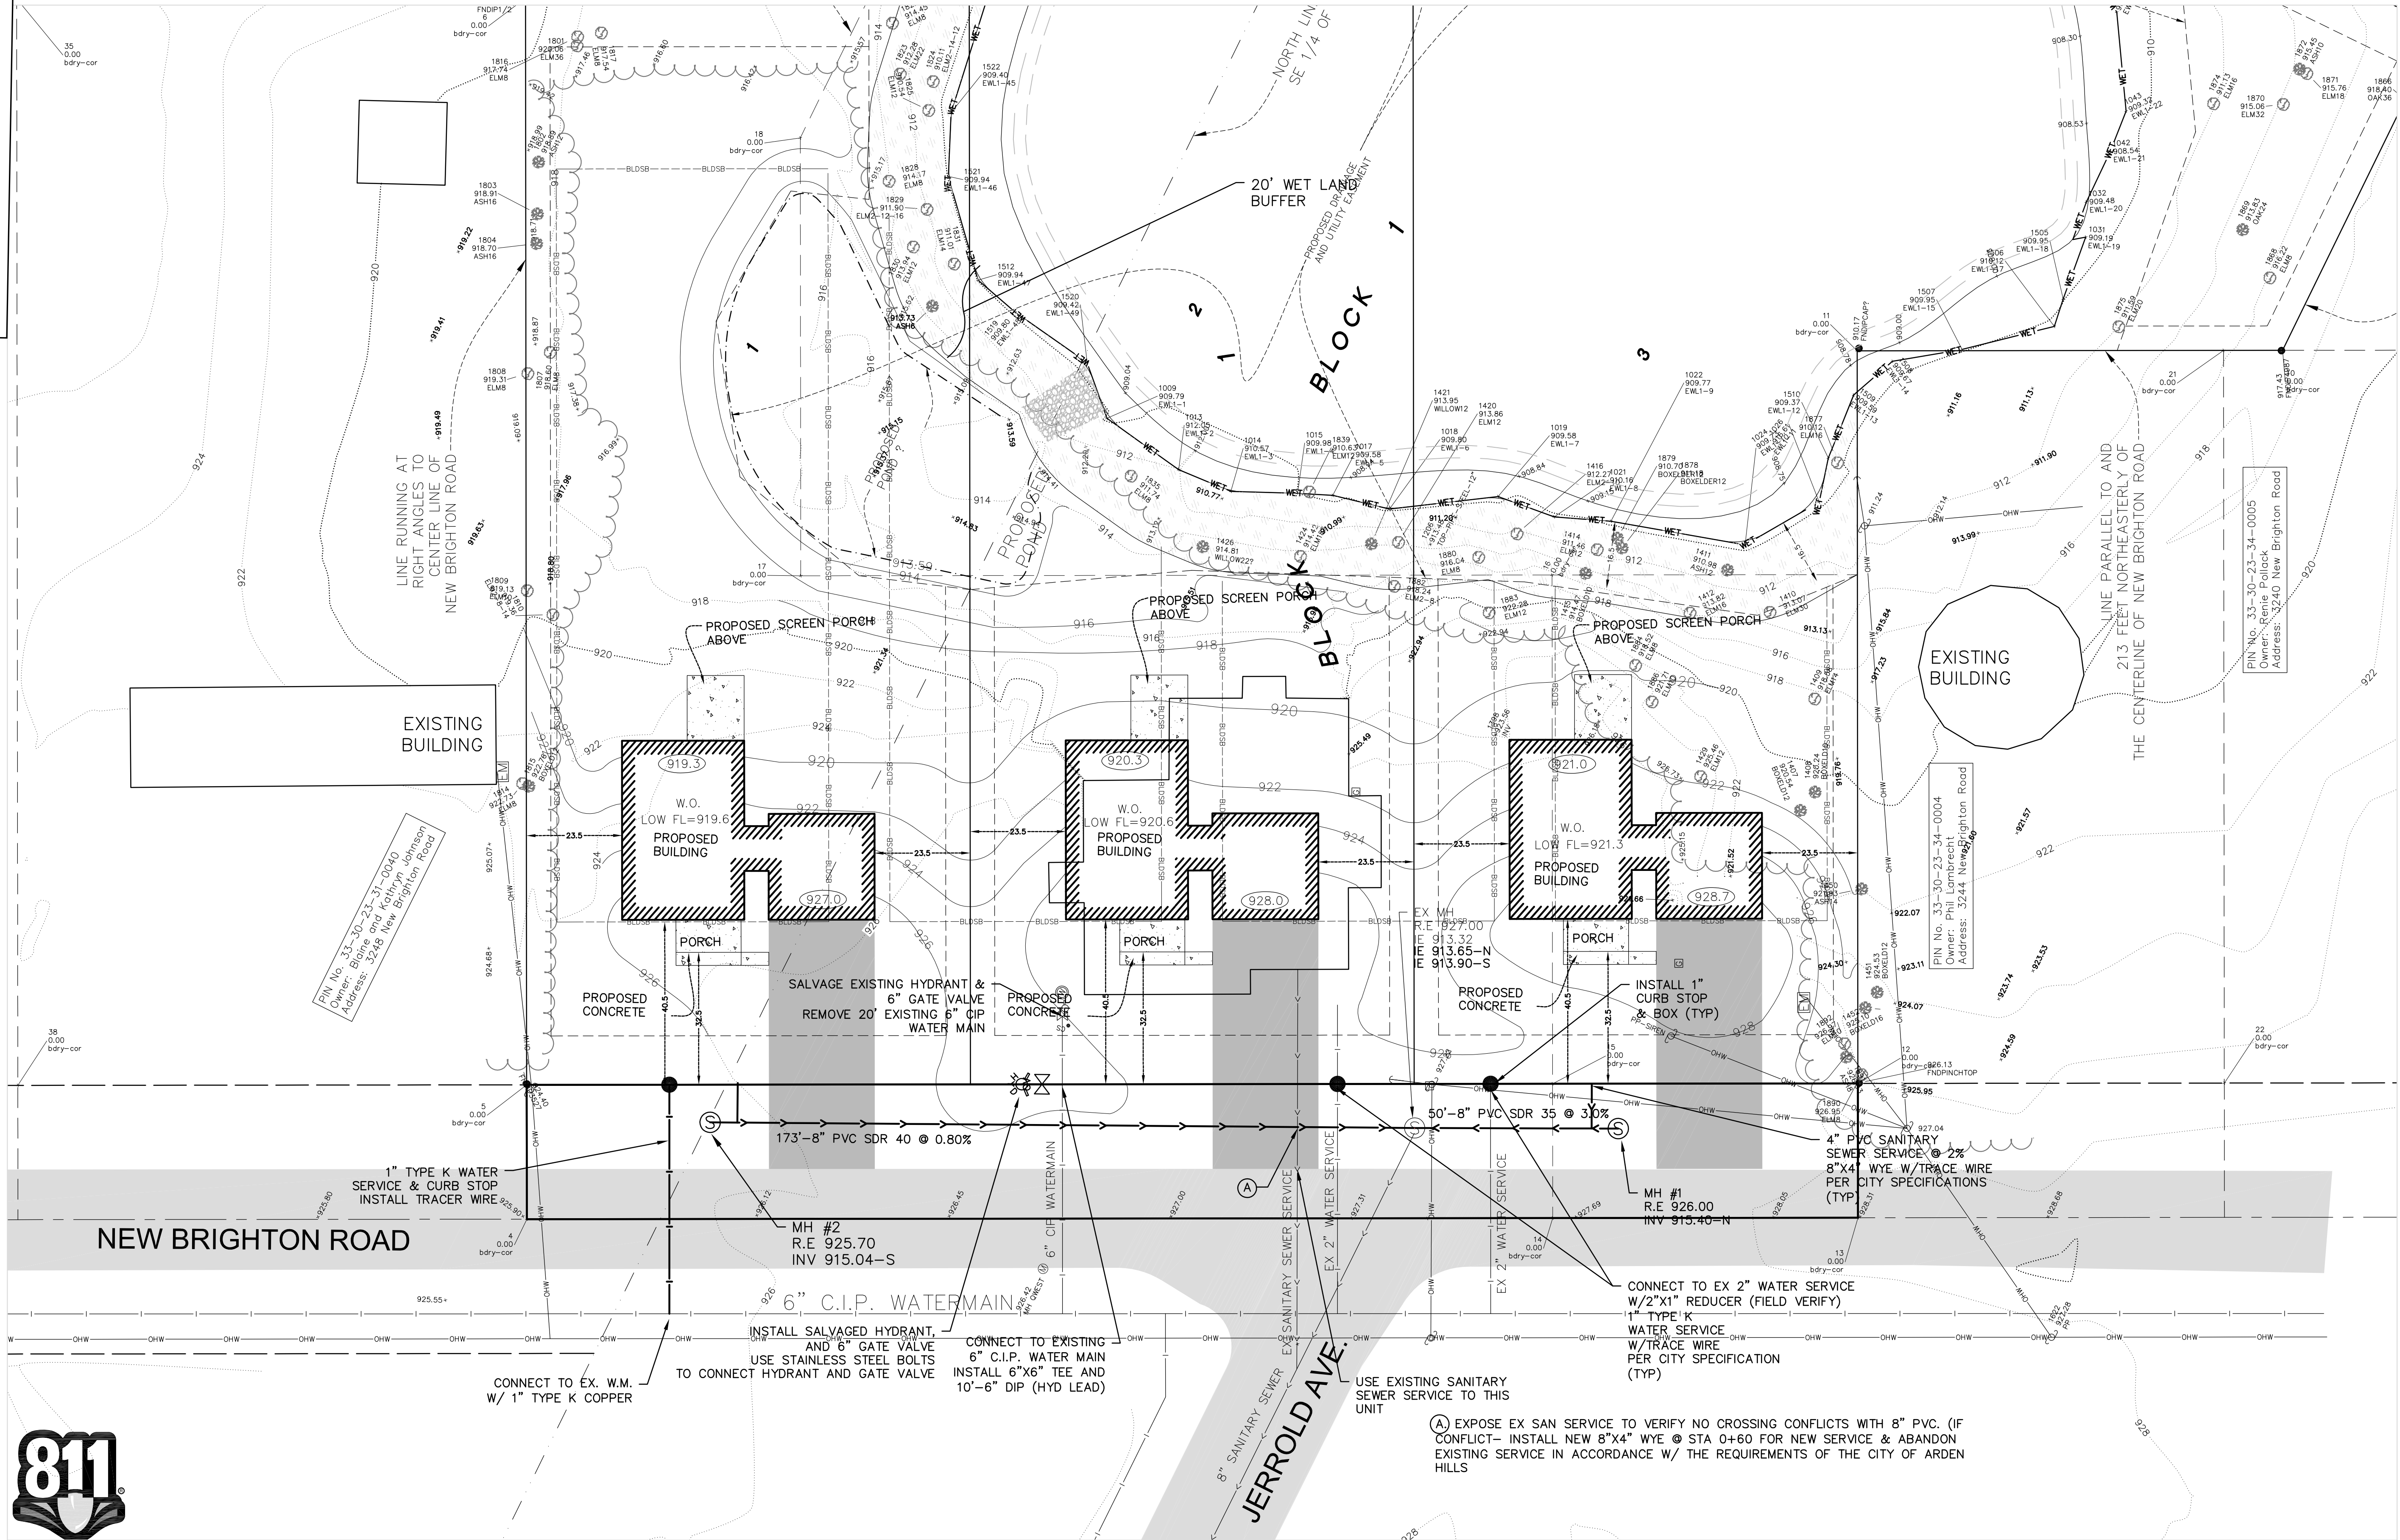

Know what's below.
Call before you dig.

**CIVIL SITE & UTILITY PLAN
LAKE JOHANNA STATION 1**